

REVISIONS:		
NO.	DATE	DESCRIPTION
1		
2		
3		
4		
5		
6		
7		
8		
9		
10		

DARIO

ARCHITECTURE DESIGN

709 ATLANTIC CITY BOULEVARD UNIT D
BEACHWOOD, NEW JERSEY 08722
T: (732) 408-6838
F: (732) 358-0236

DARIO L. PASQUARIELLO, P.A., AIA

NJ LICENSE NO. AI 17862
NY LICENSE NO. 039898
PA LICENSE NO. RA00008

EMAIL: DARIO.PASQUARIELLO@GMAIL.COM

SIGNATURE & SEAL:

PROJECT INFORMATION:

NEW CONSTRUCTION FOR THE:

DOLPHIN HOMES, LLC

LOT: 4 BLOCK: 8.08
111 E. DUNE LANE
LONG BEACH TOWNSHIP, NEW JERSEY

CONTENT:

- WALL SECTION
- PILE PLAN/ LOWER LEVEL PLAN
- DETAILS

JOB NUMBER: 21137

DATE: 6-18-21

DRAWN BY: D.P.

A2

SHEET NUMBER: 2 OF 5

DARIO
ARCHITECTURE | DESIGN



SIGNATURE & SEAL:




DOLPHIN HOMES, LLC


LOT: 4 BLOCK: 8.08
111 E. DUNE LANE
LONG BEACH TOWNSHIP, NEW JERSEY

- FIRST FLOOR PLAN
- SECOND FLOOR PLAN
- ROOF FRAMING PLAN
- DETAILS


DRAWN BY: D.P.

SHEET NUMBER: 3 OF 5

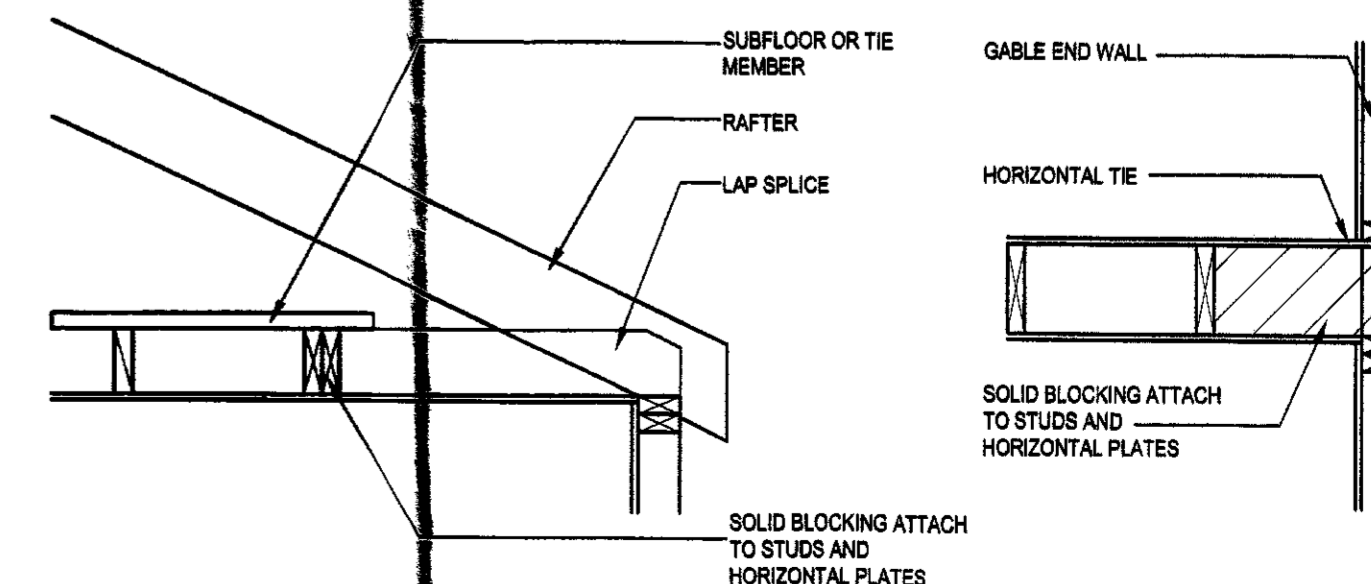

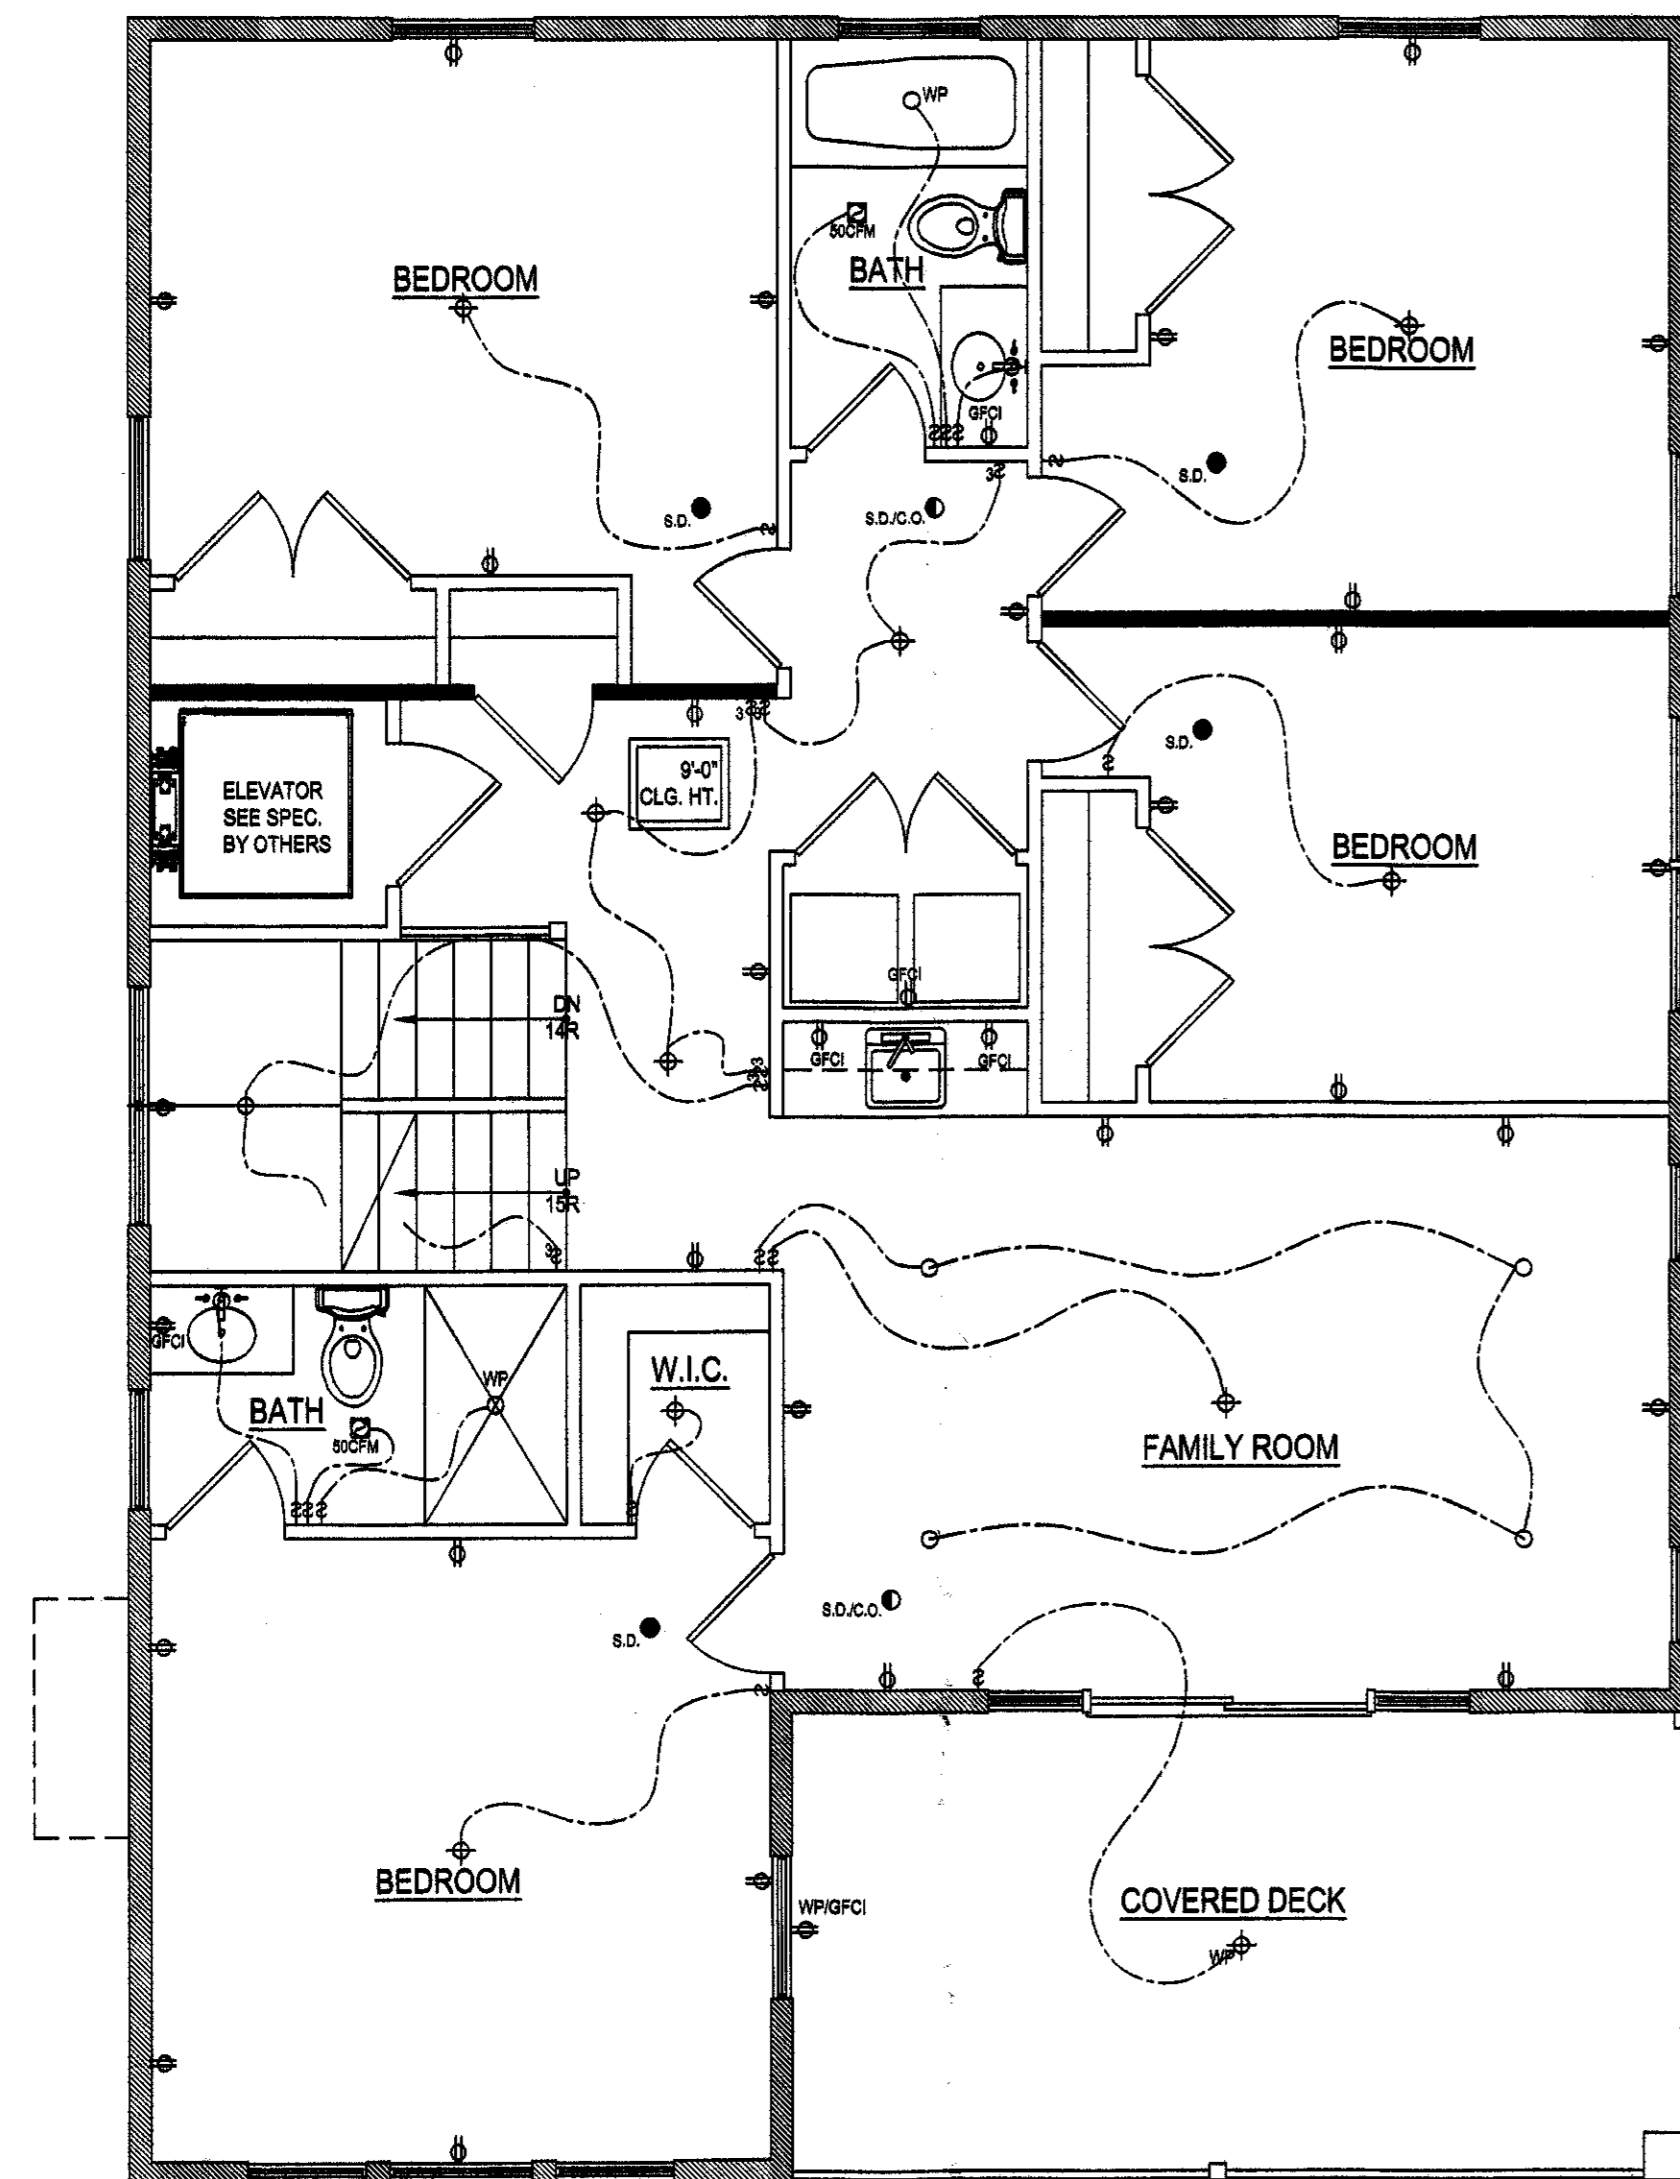

1 FIRST FLOOR BRACED WALL & ELECTRICAL PLAN
A4 SCALE 1/8"=1'

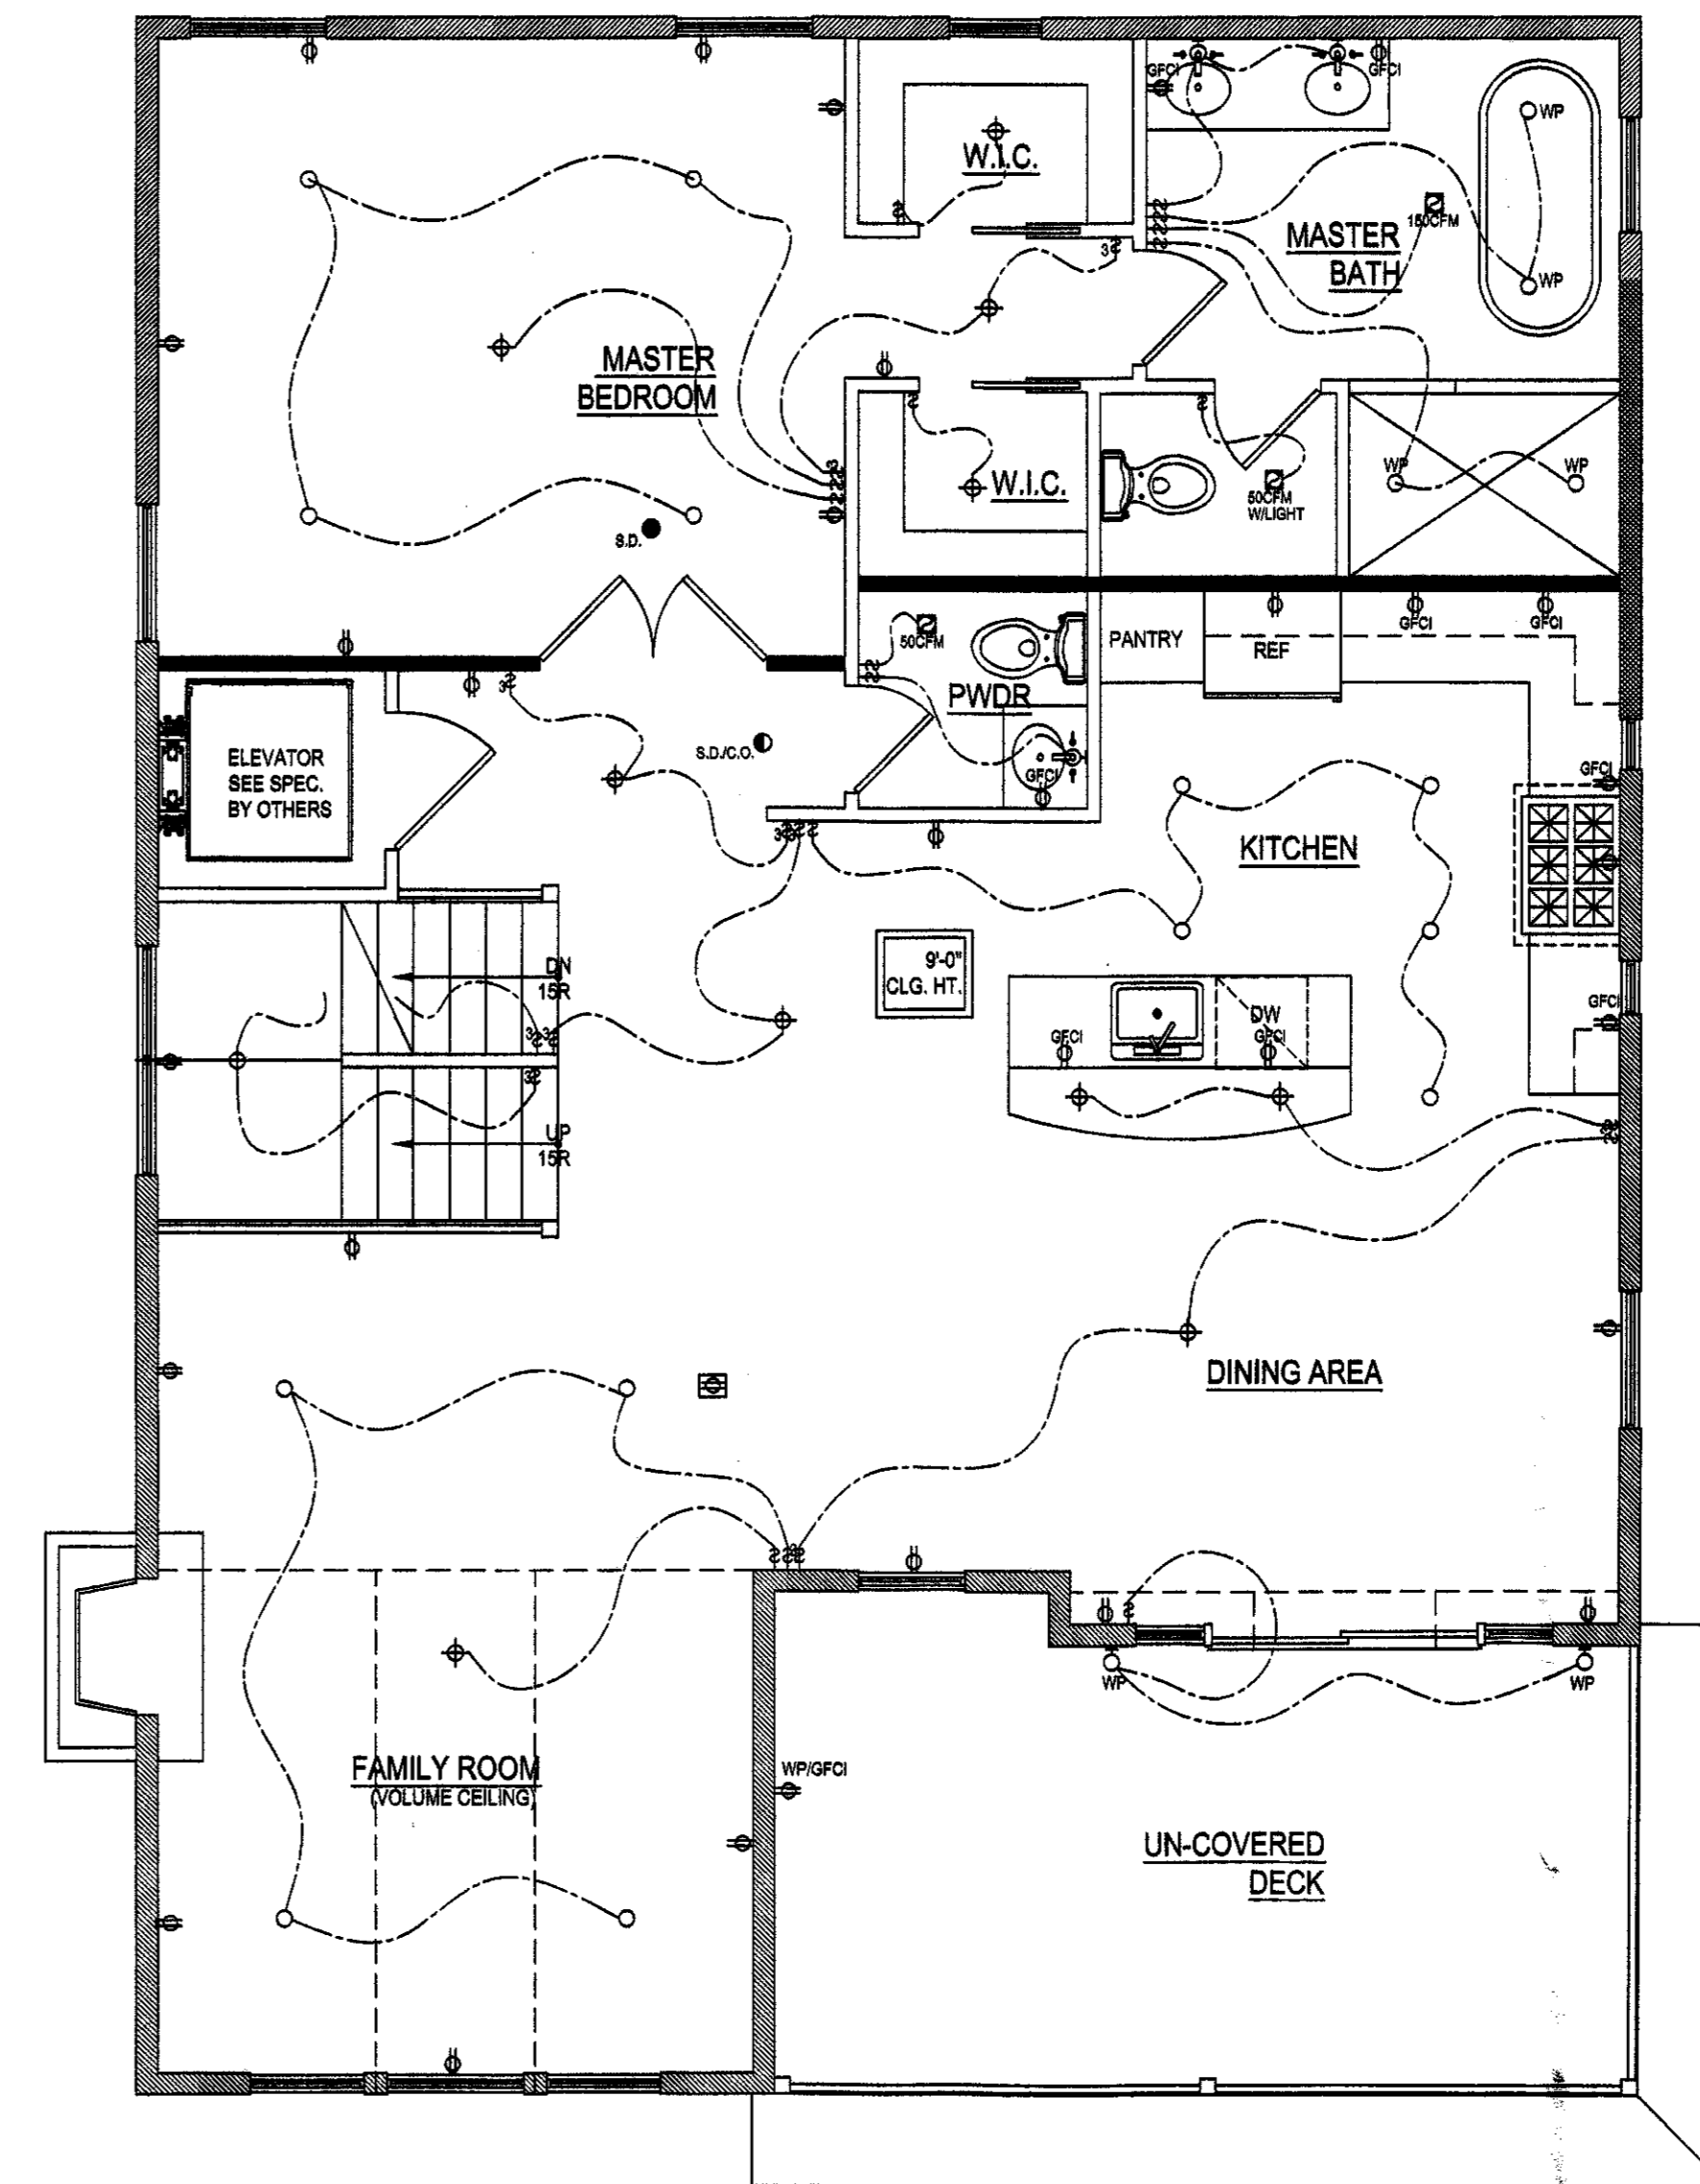

2 SECOND FLOOR BRACED WALL & ELECTRICAL PLAN
A4 SCALE 1/8"=1'

ELECTRICAL SYMBOLS


	DUPLEX RECEPTACLE		SWITCH
	3-WIRE 220V RECEPTACLE		SWITCH - 3 WAY
	QUADPLEX RECEPTACLE		SWITCH - 4 WAY
	FLOOR OUTLET		SWITCH - TIMER
	OVERHEAD GARAGE DOOR OPENER		SWITCH - PILOT LIGHT
	TELEPHONE RECEPTACLE		SWITCH - DIMMER
	COMPUTER/DATA RECEPTACLE		FAN SWITCH (SPD CONTROL)
	SMOKE DETECTOR / CARBON MONOXIDE DETECTOR		CABLE TV RECEPTACLE
	HARDWIRED SMOKE DETECTOR W/ BATTERY BACK-UP		EXHAUST FAN
	HARDWIRED HEAT DETECTOR W/ BATTERY BACK-UP		RECESSED WALL WASHER
	RECESSED DOWNLIGHT		CEILING MOUNTED LIGHT FIXTURE
	WALL MOUNTED LIGHT FIXTURE		UNDER CABINET LIGHT FIXTURE
	FLOOD LIGHT		LIGHT WITH FAN
	CEILING MOUNTED EXIT SIGN-ARROWS INDICATE DIRECTION OF EGRESS WITH BATTERY BACK UP		CEILING MOUNTED EXIT SIGN
	FLUORESCENT LIGHT FIXTURE		200 AMP ELEC. SERVICE PANEL
	WALL MOUNTED EMERGENCY LIGHT WITH BATTERY BACK UP		CEILING FAN
	GROUND FAULT INTERRUPT		FLUORESCENT CLOSET LIGHT
	WATER PROOF RECEPTACLE		MOUNT IN CABINET
			COUNTER HEIGHT
			PULL CHAIN

WALL BRACING LEGEND

	2X STUD WALL WITH 1/2" BLOCKED PLYWOOD SHEATHING NAILED W/ 8d COMMON NAILS 4" O.C. EDGE SPACING & 12" GYP BD. INTERIOR W/ 5d COOLER NAILS @ 7" EDGE SPACING
	2X STUD WALL WITH (1) SIDE 1/2" BLOCKED PLYWOOD SHEATHING NAILED W/ 8d COMMON NAILS 4" O.C. EDGE SPACING & (1) SIDE 5/8" GYP BD. INTERIOR W/ 5d COOLER NAILS @ 7" EDGE SPACING


NO.	DATE	DESCRIPTION
1		
2		
3		
4		
5		
6		
7		
8		
9		
10		

DARIO
ARCHITECTURE | DESIGN

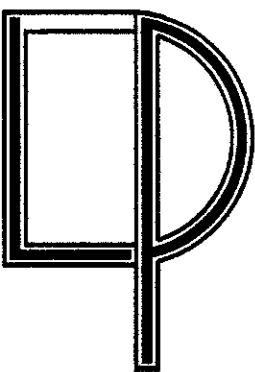

709 ATLANTIC CITY BOULEVARD UNIT D
BEACHWOOD, NEW JERSEY 08722
T: (732) 408-6838
F: (732) 358-0238
DARIO L. PASQUARIELLO, P.A., A.I.A.
NJ LICENSE NO. A1 17852
PA LICENSE NO. 033066
PA LICENSE NO. 04400008
EMAIL: DARIO.PASQUARIELLO@GMAIL.COM

SIGNATURE & SEAL:

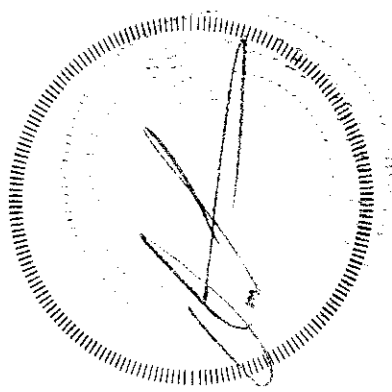

PROJECT INFORMATION:

NEW CONSTRUCTION FOR THE:
DOLPHIN HOMES, LLC
LOT: 4 BLOCK: 8.08
111 E. DUNE LANE
LONG BEACH TOWNSHIP, NEW JERSEY

CONTENT:
○ FIRST FLOOR BRACED WALL PLAN
○ SECOND FLOOR BRACED WALL PLAN
○ DETAILS

 
JOB NUMBER: 21137

DATE: 6-18-21

DRAWN BY: D.P.

A4

SHEET NUMBER: 4 OF 5




NOTE:
WINDOW MODEL #S SPECIFIED ARE
ANDERSEN 400 SERIES OR APPROVED
EQUAL

NOTE:
ALL WINDOWS 6'-0" A.F.F ARE TO HAVE
MIN. SILL HEIGHT OF 24"



REVISIONS:		
NO.	DATE	DESCRIPTION
1		
2		
3		
4		
5		
6		
7		
8		
9		
10		


DARIO
ARCHITECTURE | DESIGN

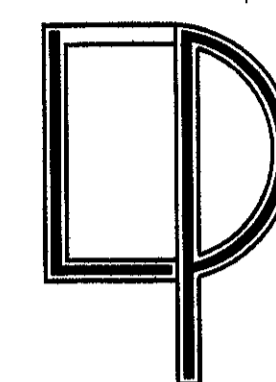

709 ATLANTIC CITY BOULEVARD UNIT D
BEACHWOOD, NEW JERSEY 08722
T:(732)-808-8838
F:(732)-358-0236

DARIO L. PASQUARIELLO, R.A., A.I.A.
NJ LICENSE NO. AJ 17852
NY LICENSE NO. 033696
PA LICENSE NO. RA408006
EMAIL: DARIOPASQUARIELLO@GMAIL.COM

SIGNATURE & SEAL

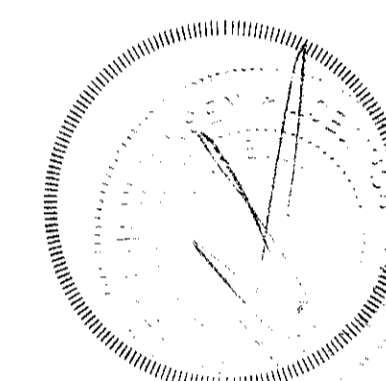

PROJECT INFORMATION:

NEW CONSTRUCTION FOR THE :

DOLPHIN HOMES. LLC

LOT: 4 BLOCK: 8.08
111 E. DUNE LANE
ONG BEACH TOWNSHIP, NEW JERSEY

CONTENT:

- ELEVATIONS
- DETAILS

JOB NUMBER: 21137

DATE: 8.18.21

DRAWN BY: D.B.

A5

SHEET NUMBER: 5 OF 5